

Department of Human Resources Office Renovation


RIT

George Eastman Building
Fifth Floor
8 Lomb Memorial Dr.
Rochester, NY 14623

Bergmann
associates
architects // engineers // planners

28 East Main Street
200 First Federal Plaza
Rochester, New York 14614 - 1909
office: 585.232.5135
fax: 585.232.4625

www.bergmannpc.com

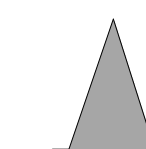

PLUMBING PLANS

Note:
Unauthorized alteration or addition to this
drawing is a violation of the New York State
Education Law Article 145, Section 7209.

Project Manager:
R. NAPOLI
Designed By:
B. WEINBLATT
Drawn By:
B. WEINBLATT
Checked By:
D. PORTER
Date Issued:
December 15, 2009


Scale:
1/4" = 1'-0"

Project Number:
8217.00


File Name:

Drawing Number:


P-101

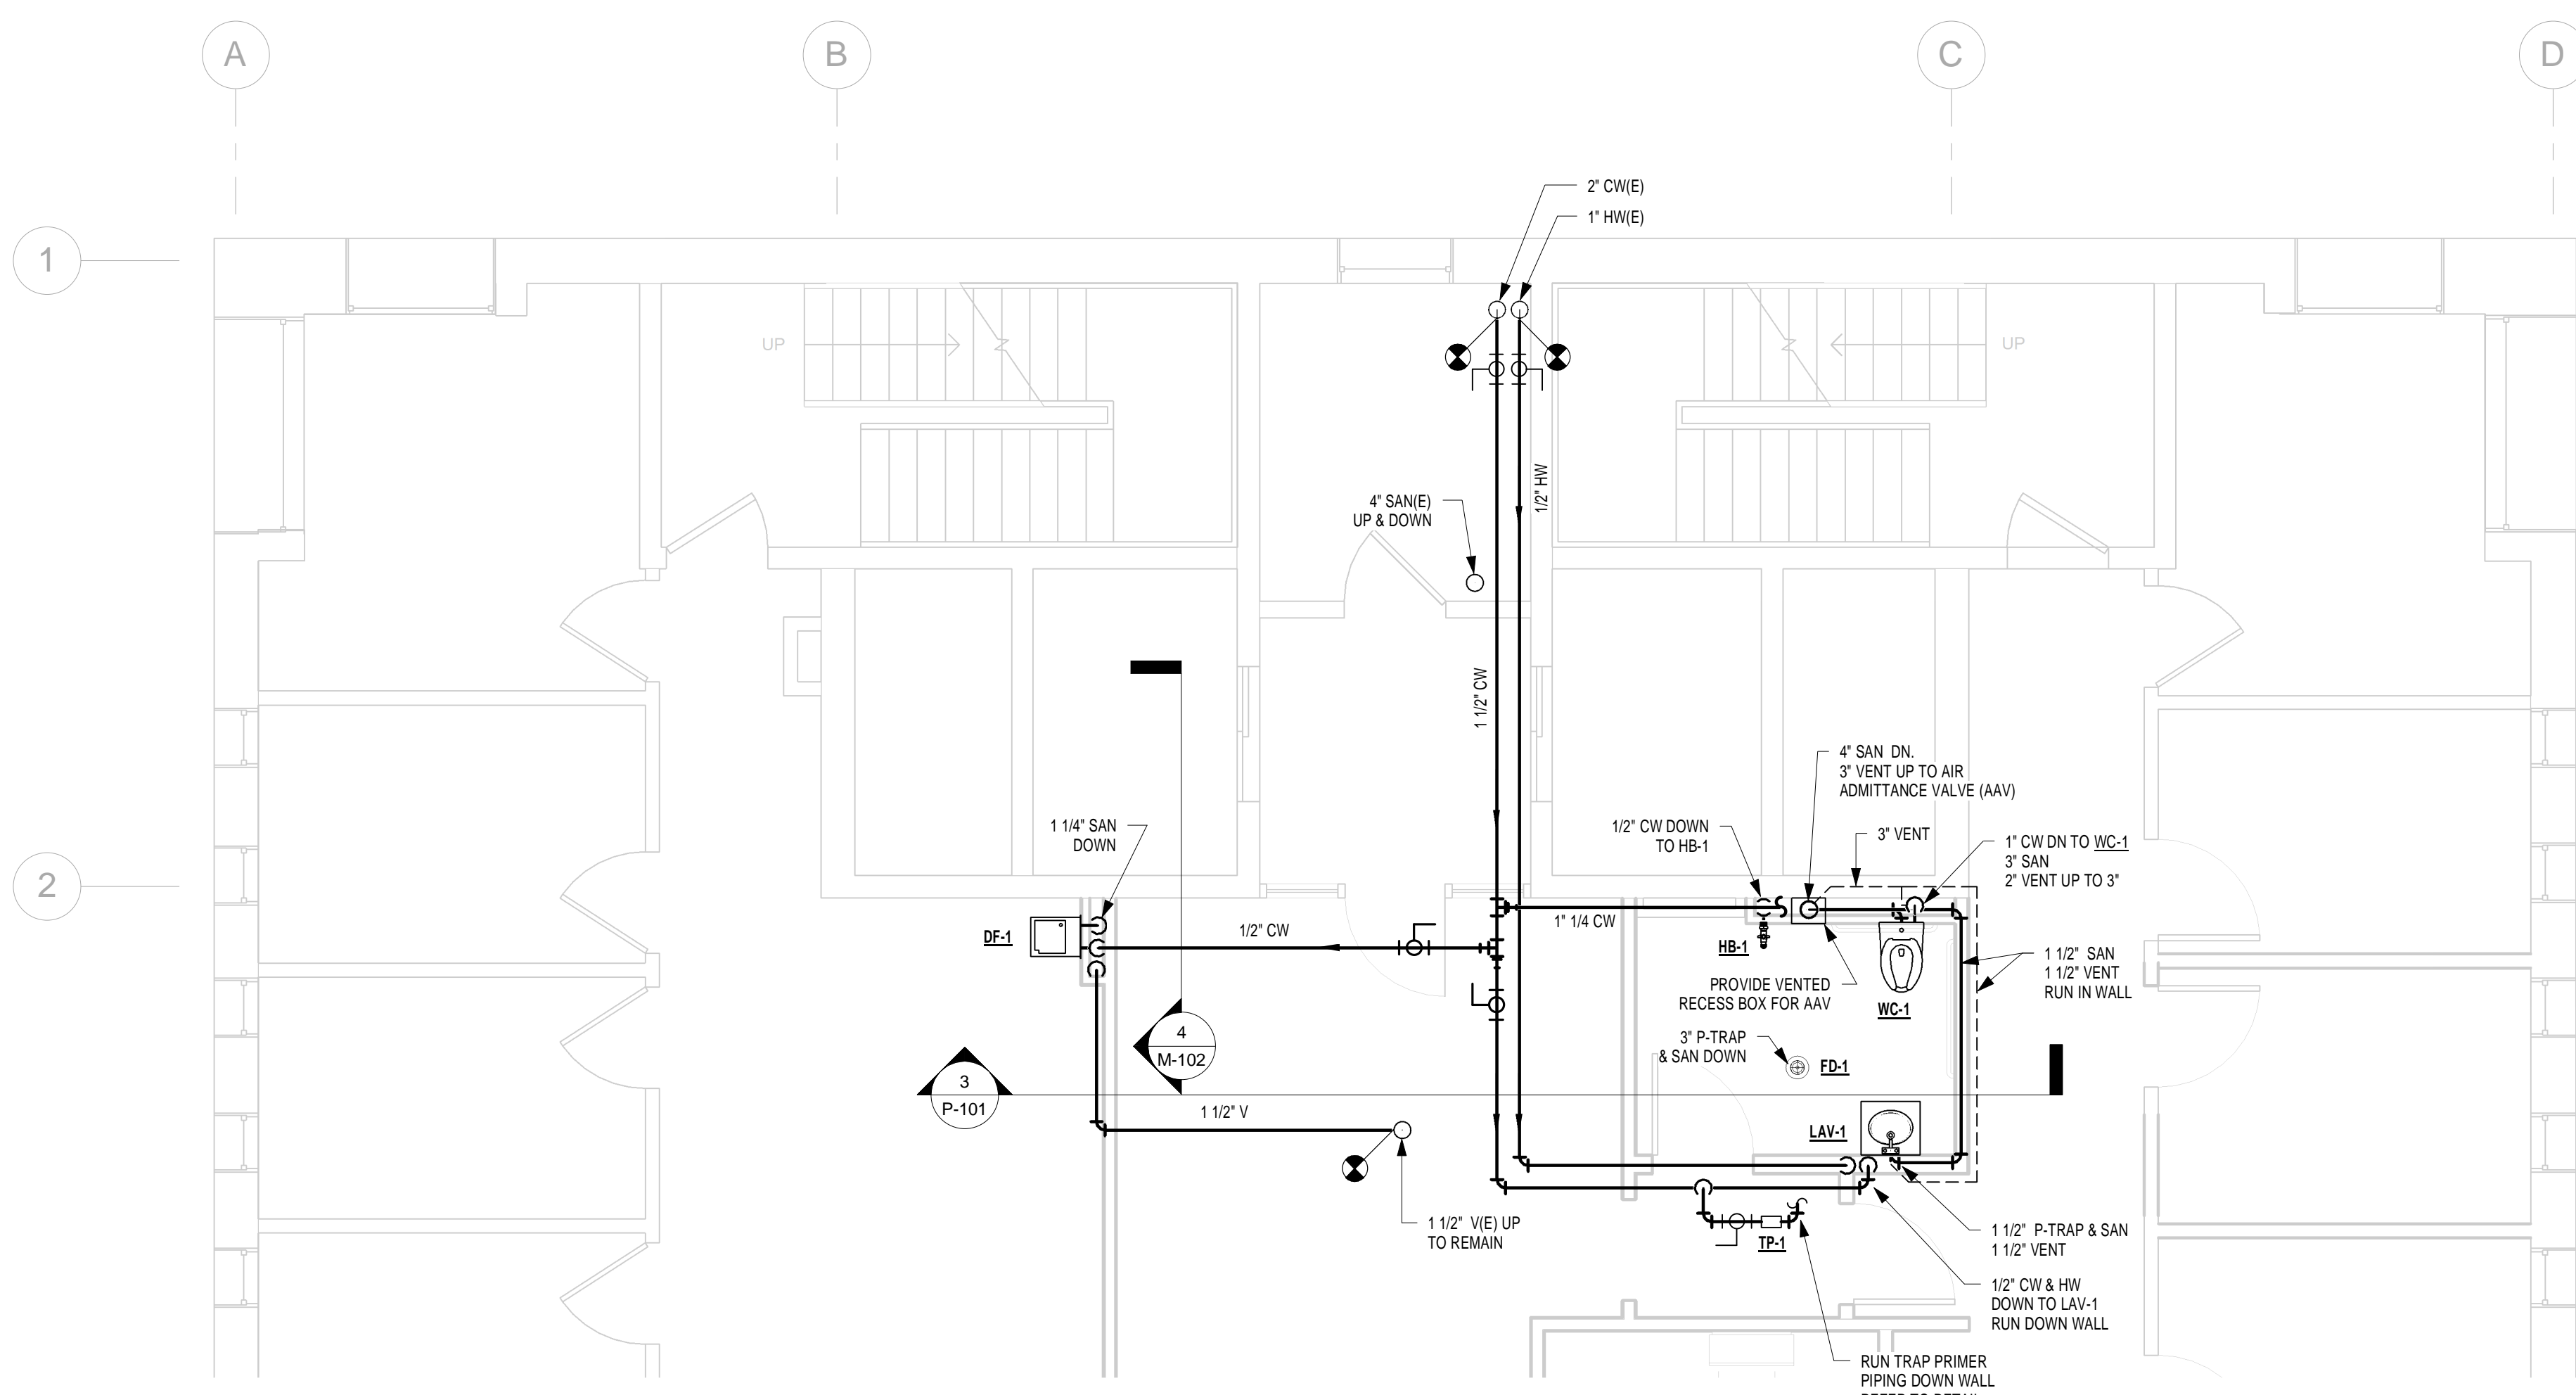

1 5TH FLOOR PLUMBING PLAN
1/4" = 1'-0"

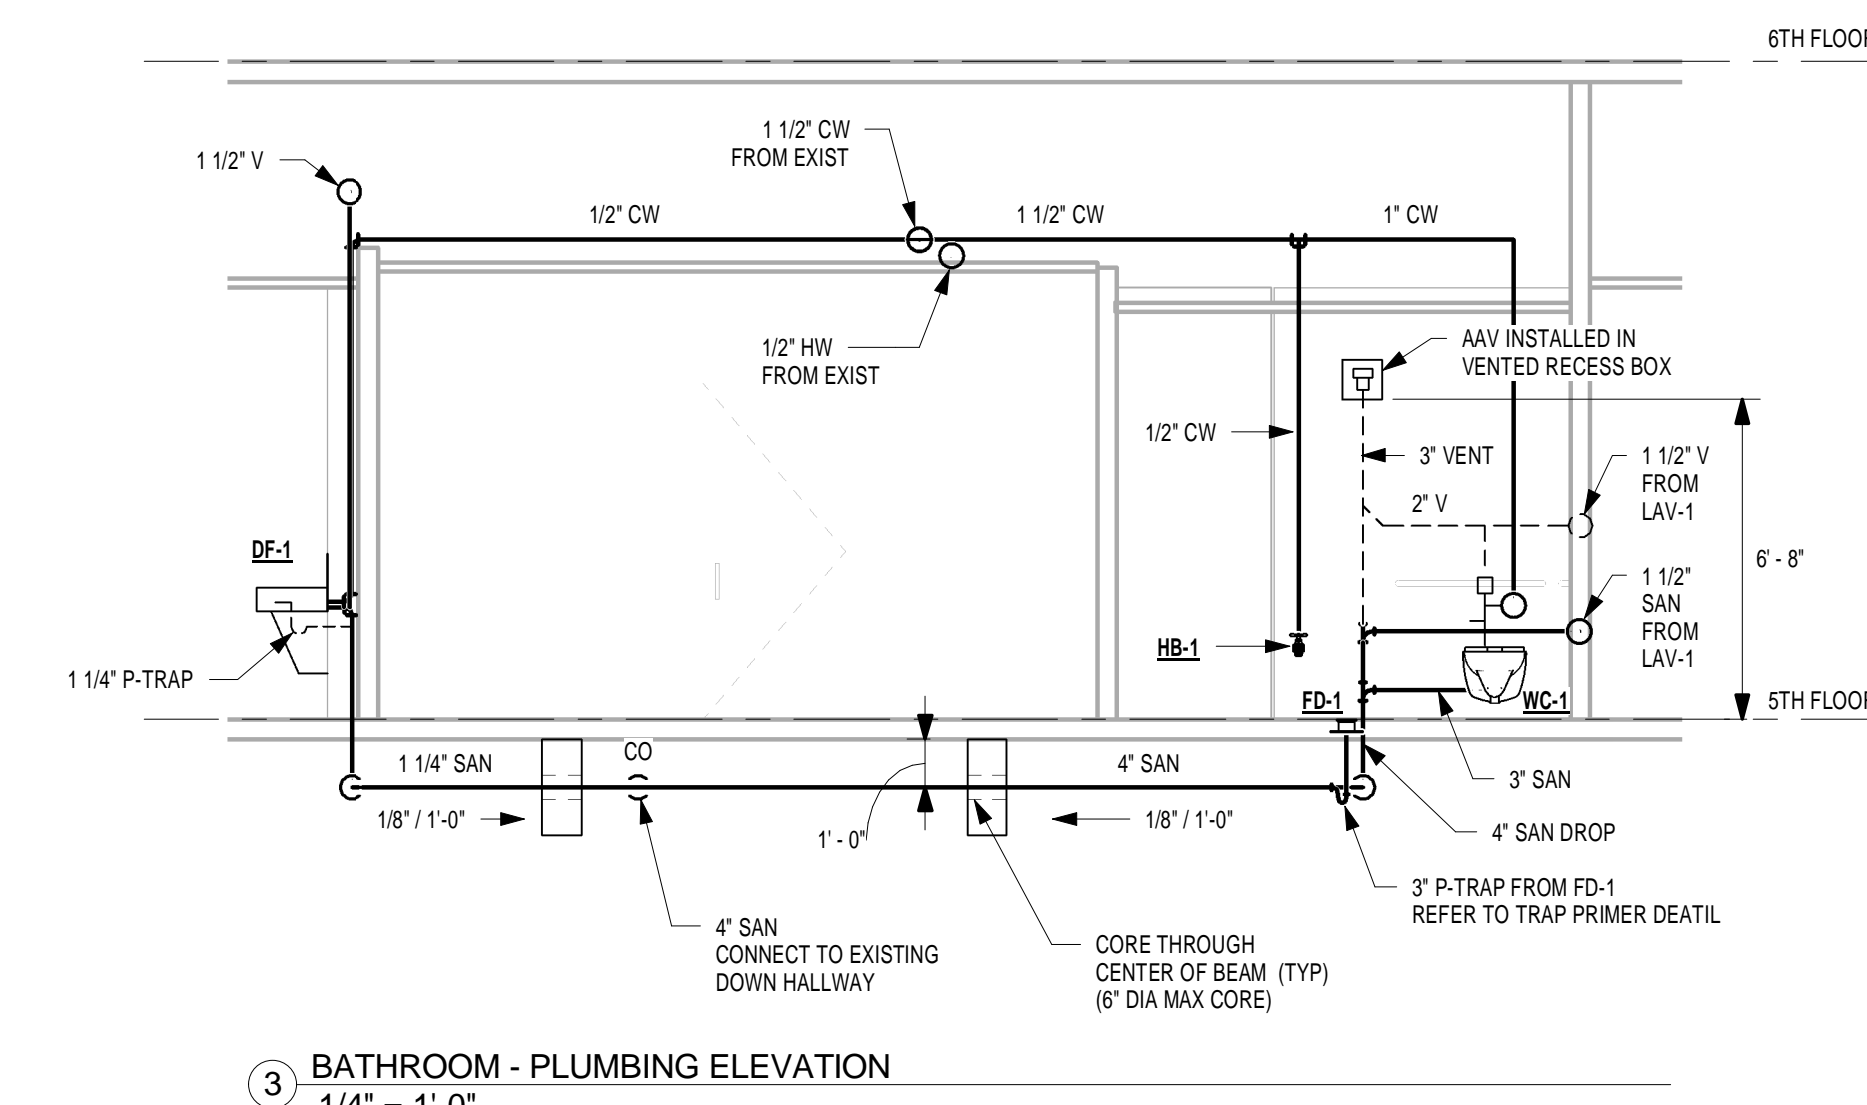

3 BATHROOM - PLUMBING ELEVATION
1/4" = 1'-0"

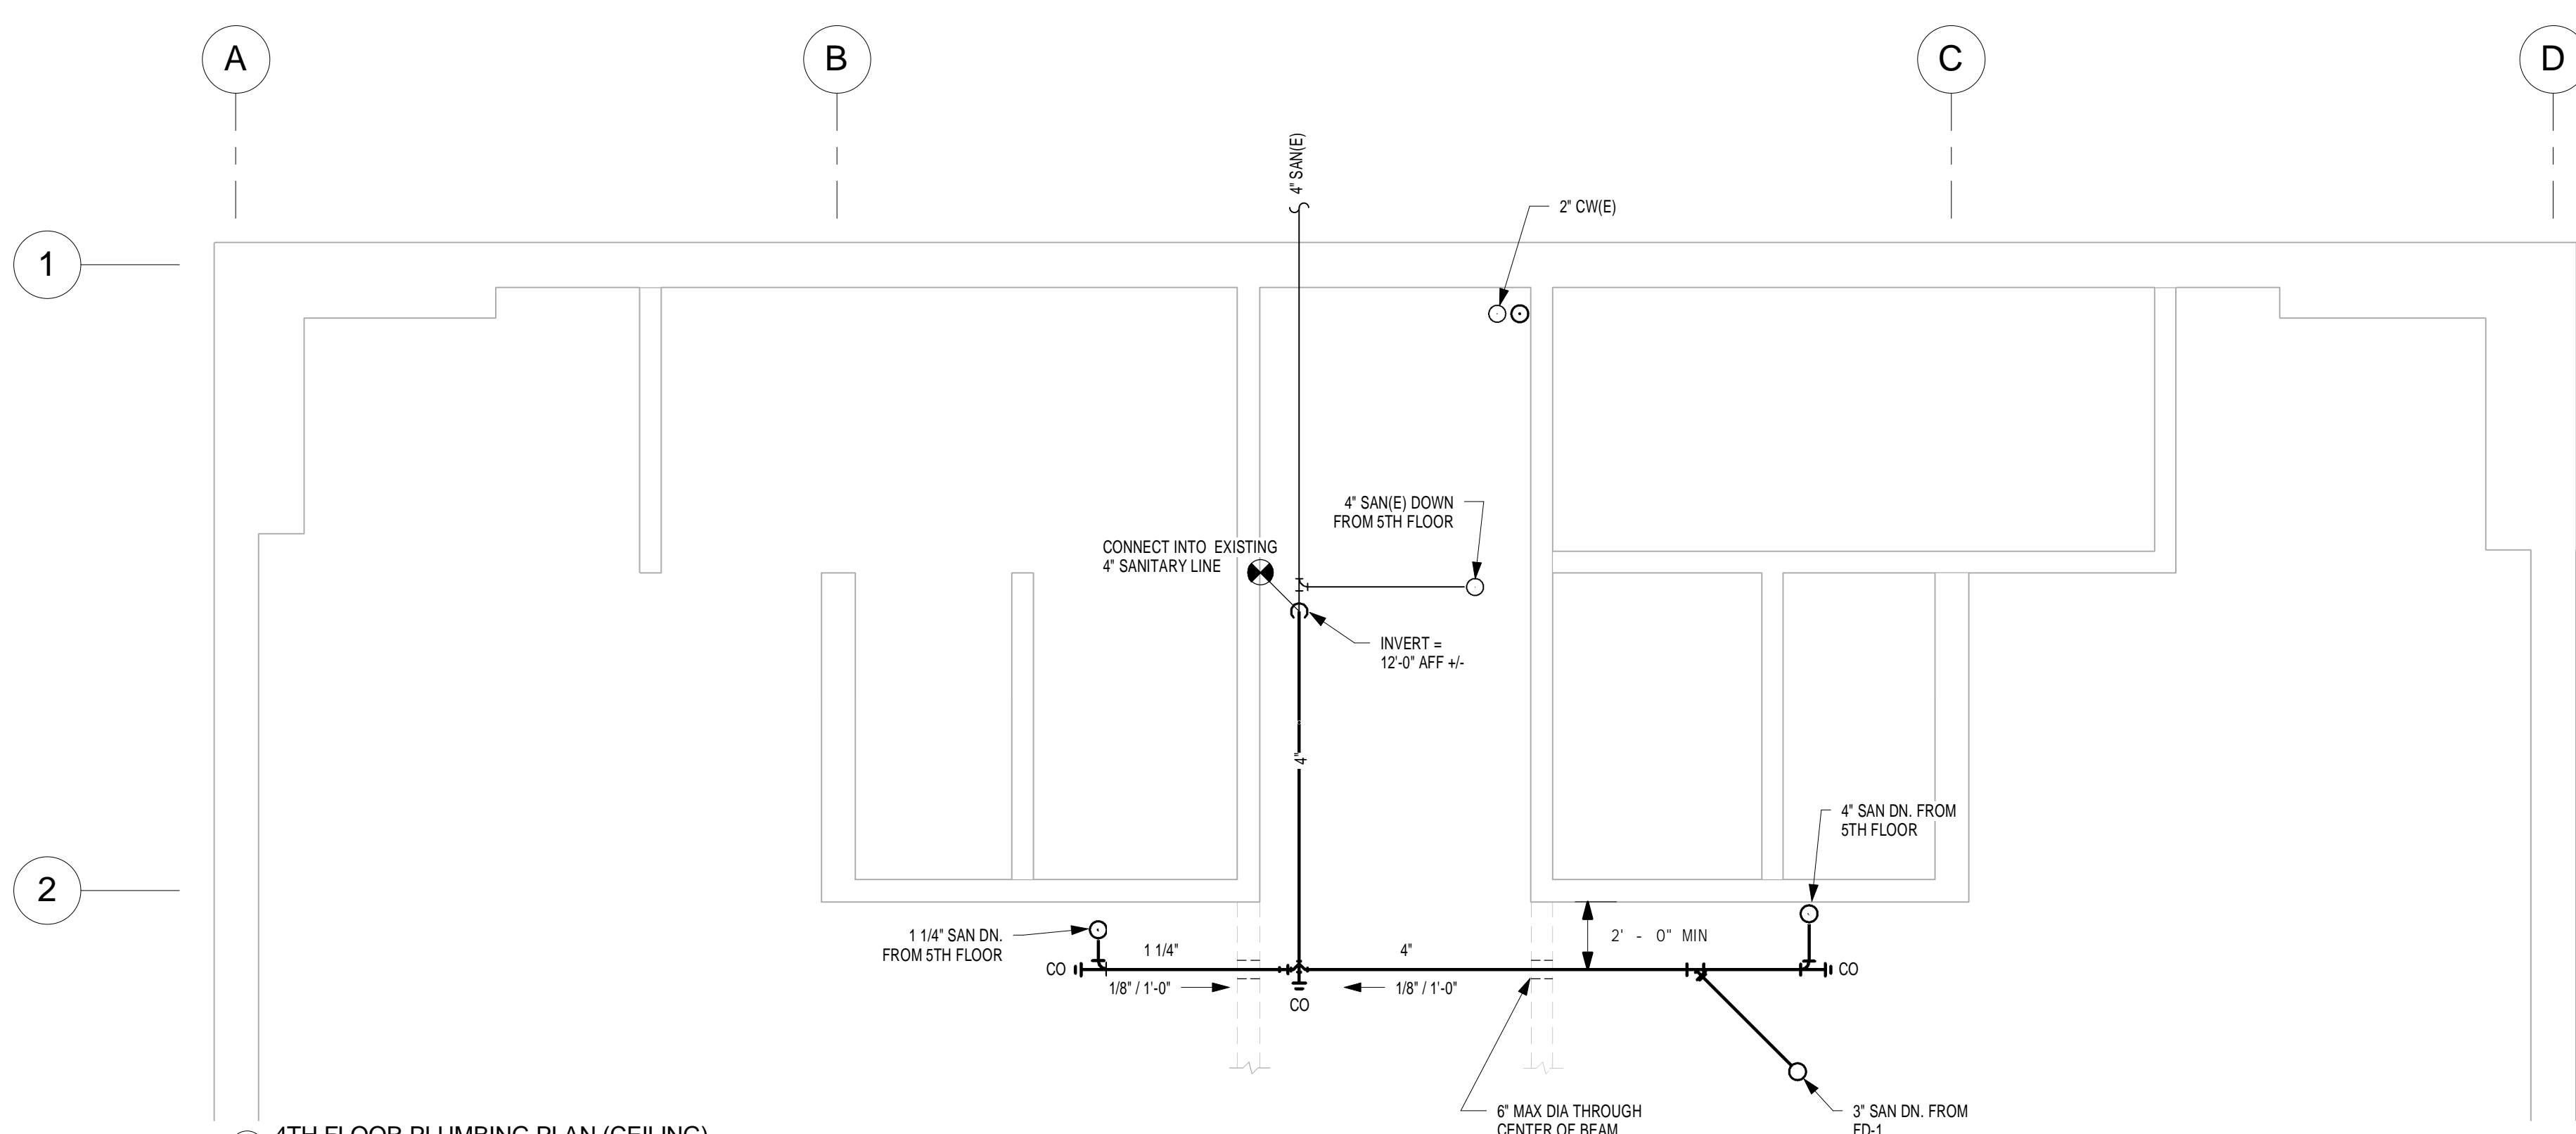

2 4TH FLOOR PLUMBING PLAN (CEILING)
1/4" = 1'-0"